


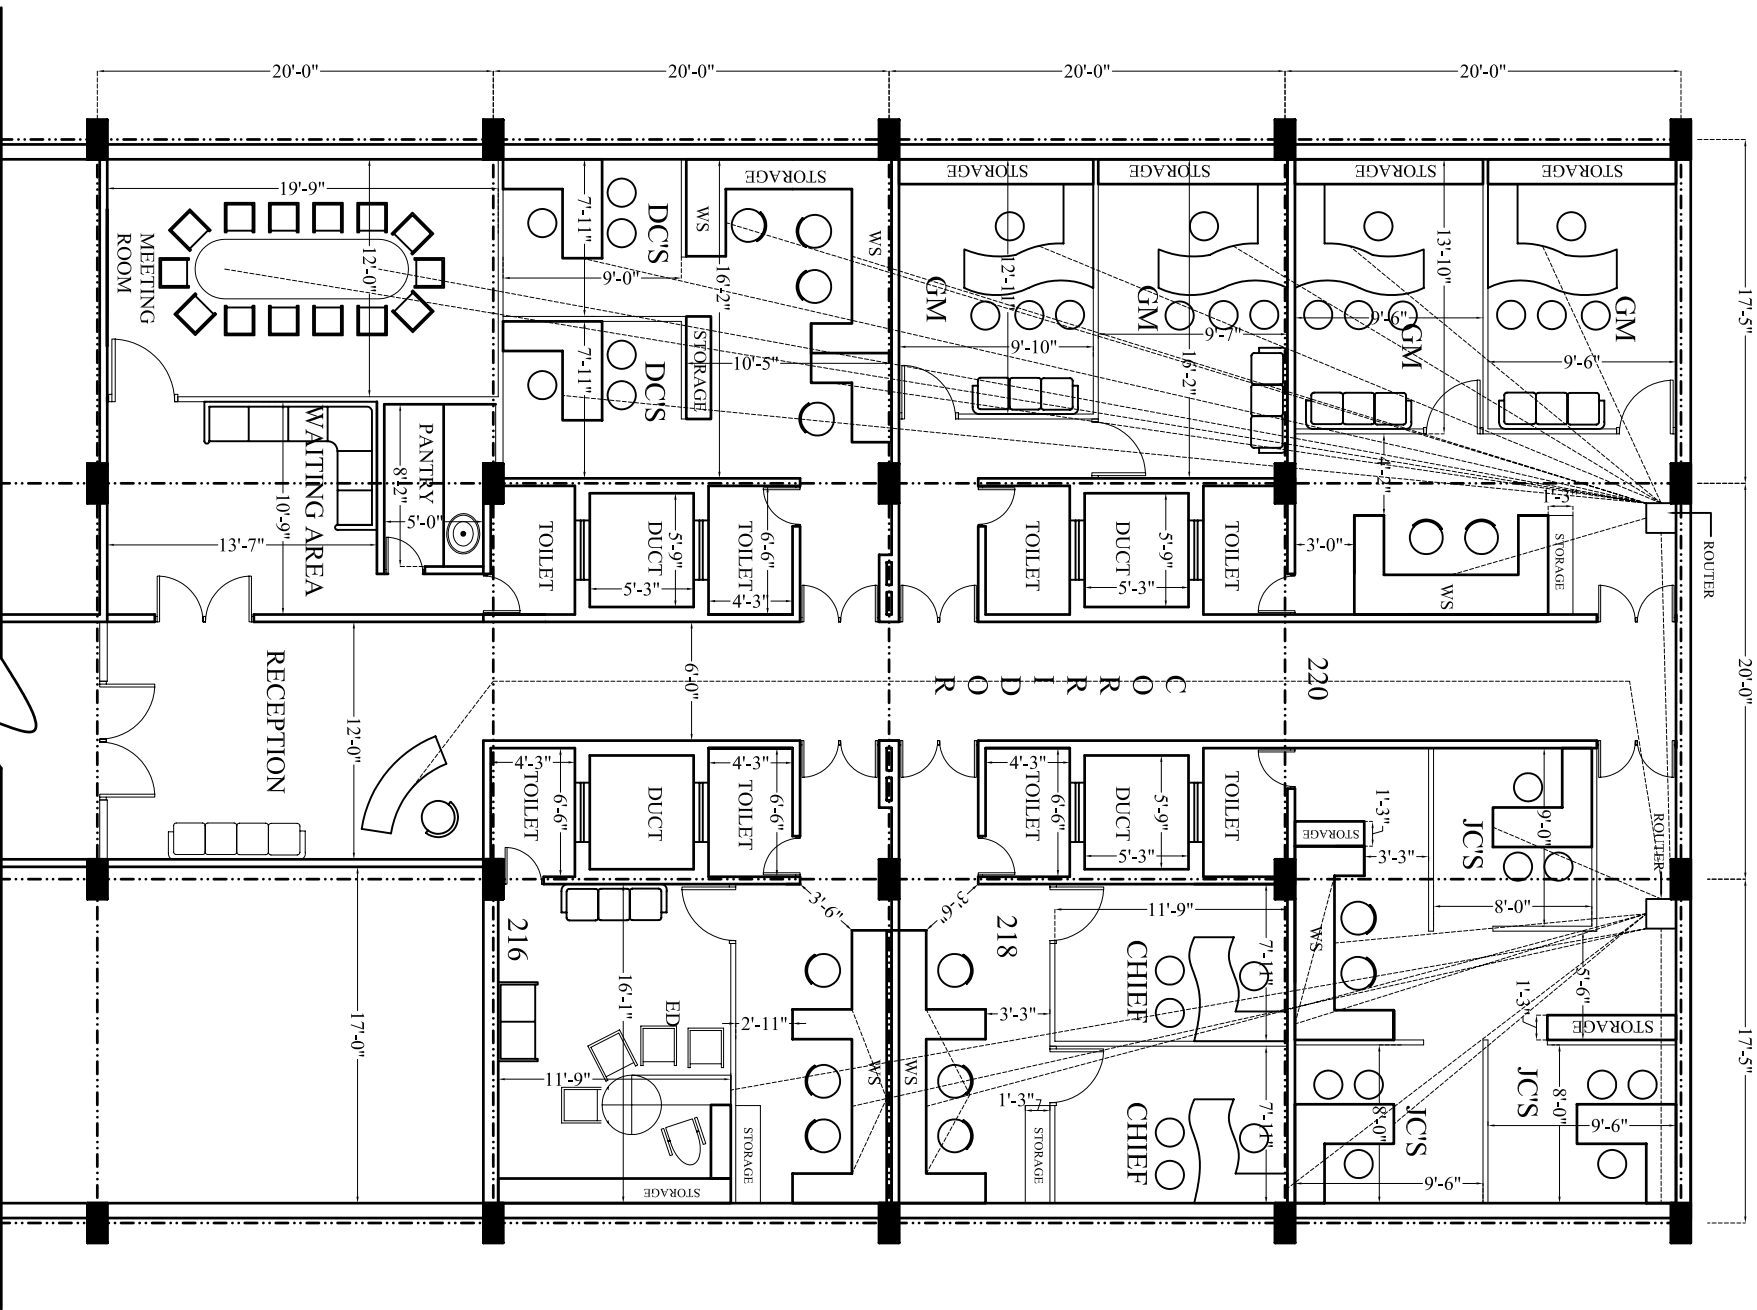

SECOND FLOOR PLAN

NOTE
this drawing is the property of
architects atelier/architects atelier pvt. ltd.
/ arch tech projects pvt. ltd. & cannot
be altered, used or copied without the
written consent of architects atelier.

FILE NAME:- ssc08 /

No	Date	Revision
RURAL ELECTRIFICATION CORPORATION LTD		
PALIKA BHAWAN ,R.K PURAM,NEW DELHI		
Title INTERIOR LAY OUT		
ROUTER OF CONDUCTING		


ami.sami	krishna.sami	s.k.sami
b.arch., mca	b.arch., m.and (USA)	b.arch., fin

Dwg No 05

Scale	Date
Debit	March 2007
PROJECT	MARCH 2007

architects atelier
architects atelier pvt. ltd.
arch tech projects pvt. ltd.

ssc08, sec-17/6
Grandgaur - 60017
tel: 7020753, 715272 mobile: 9814019753 fax: 608940

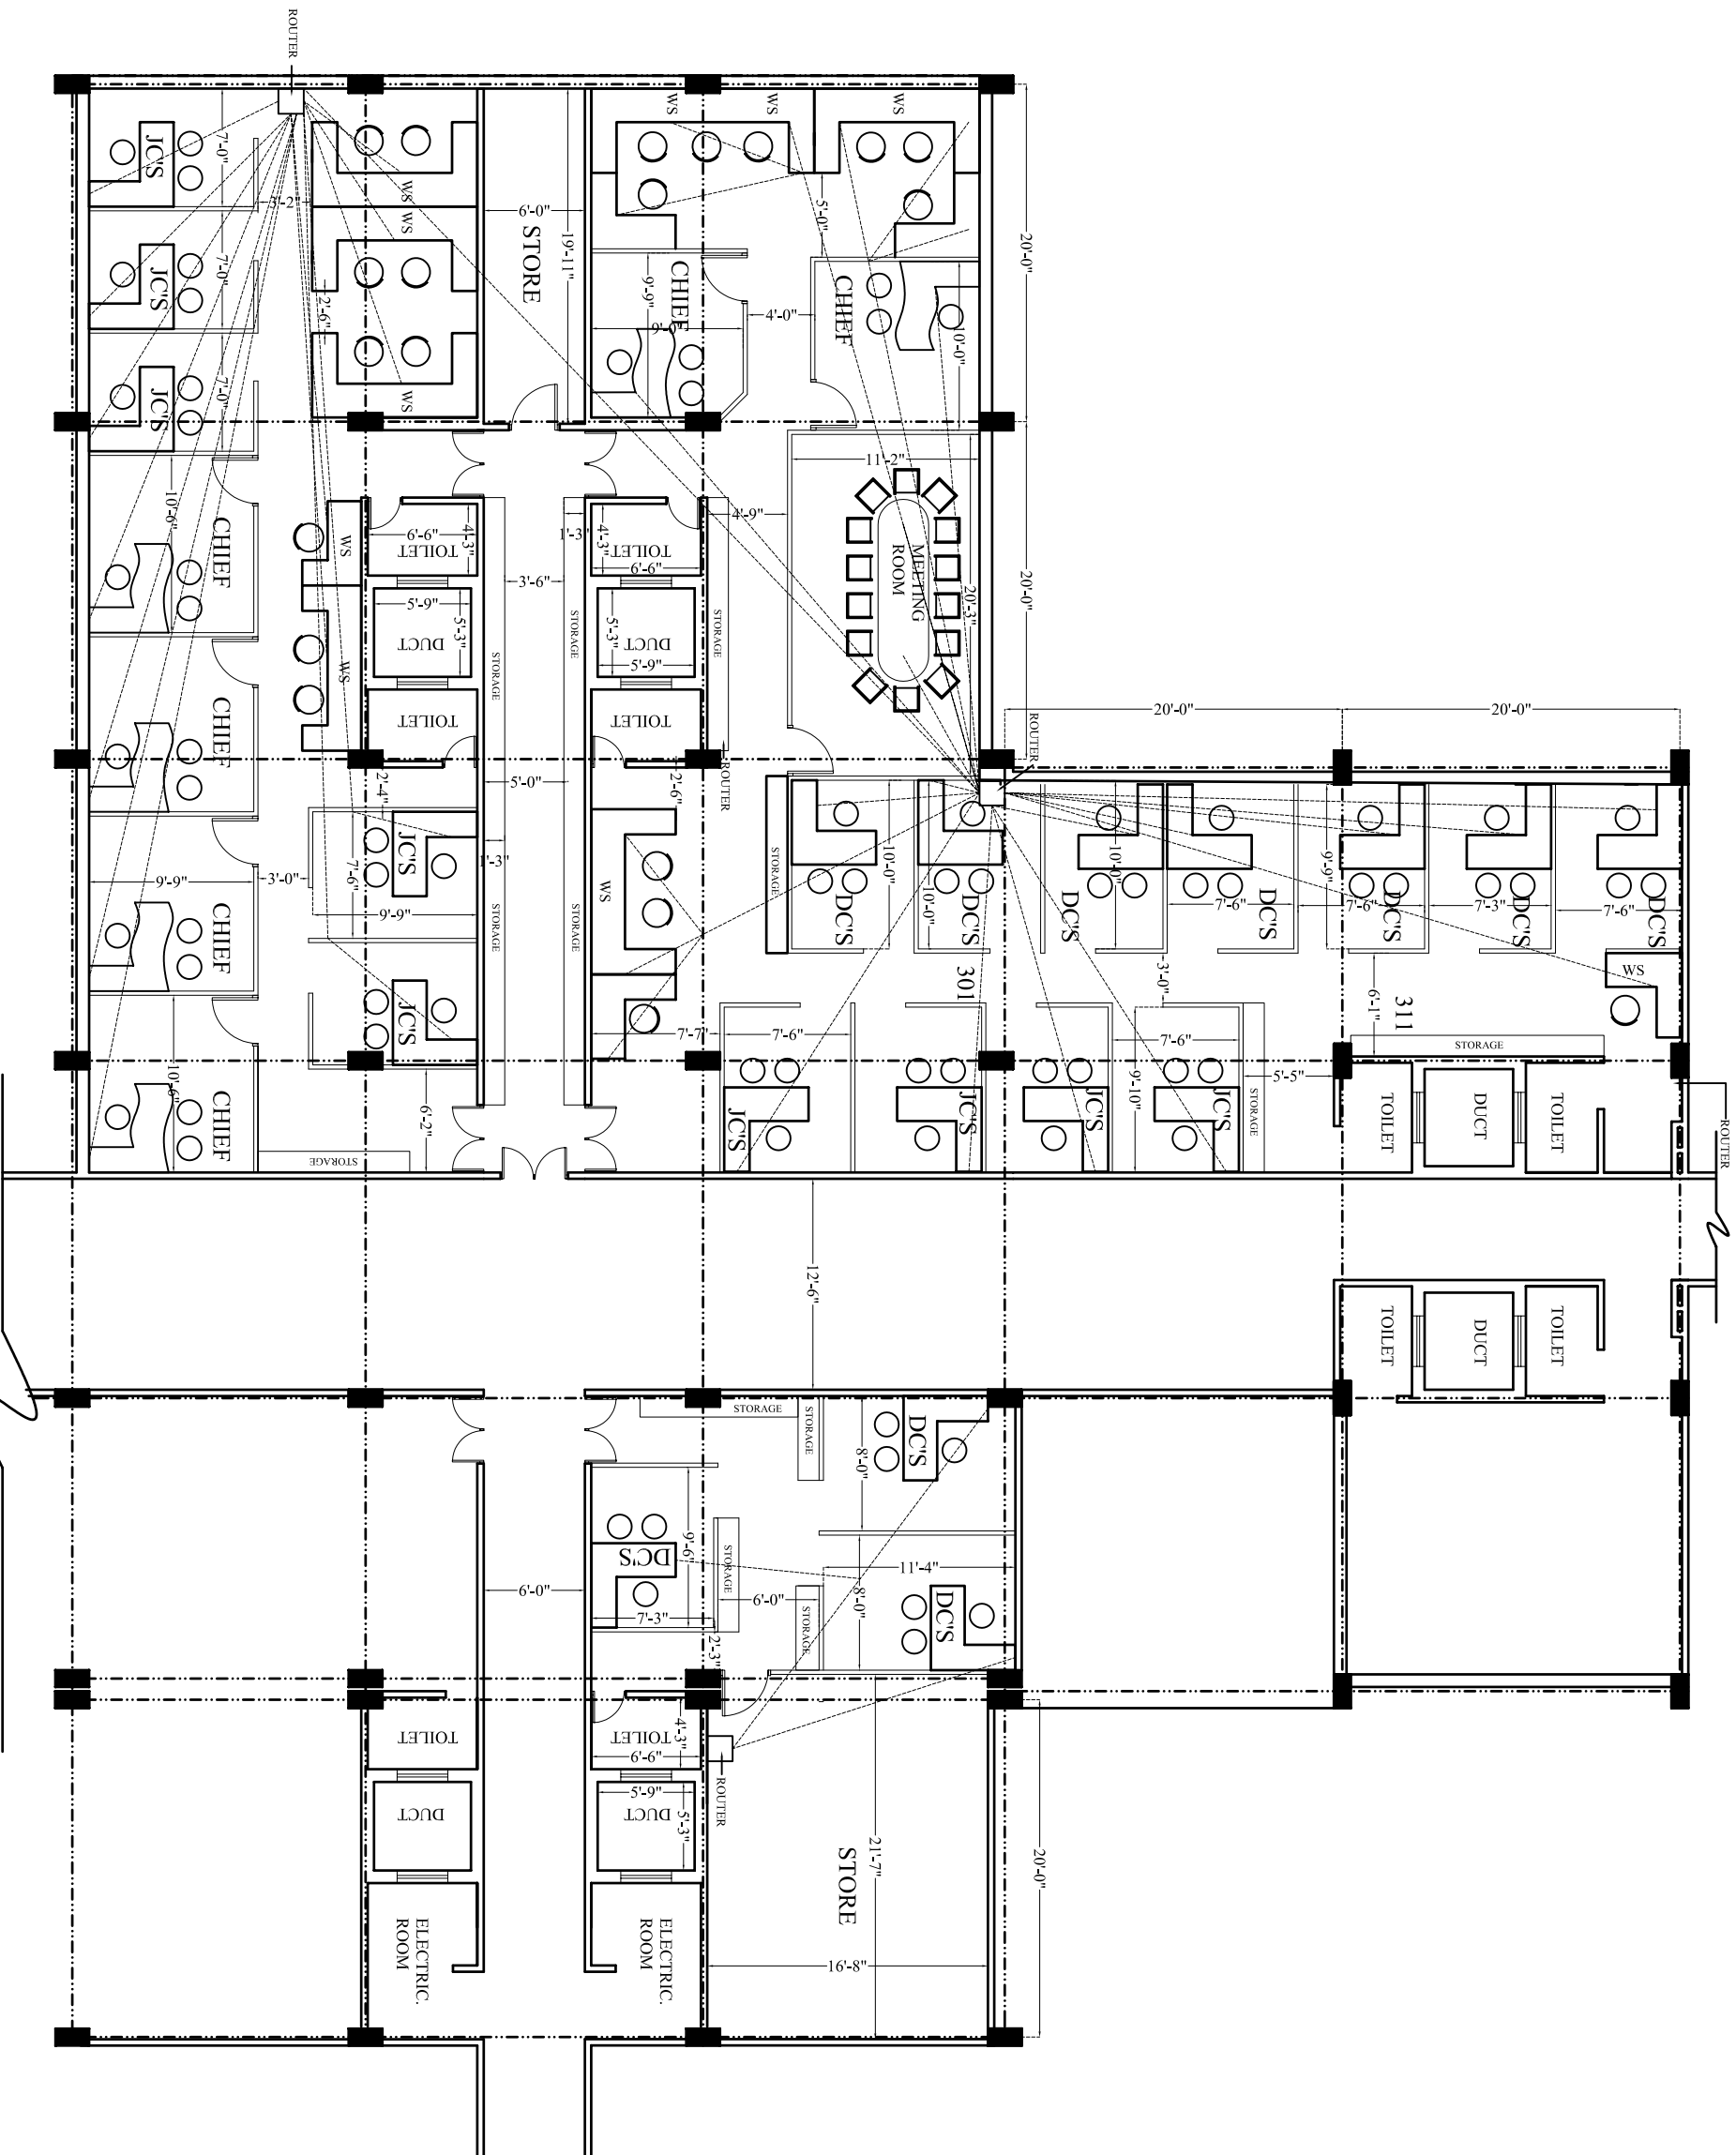

THIRDFLOOR PLAN

NOTE
this drawing is the property of
architects atelier/architects atelier pvt. ltd.
/ arch tech projects pvt. ltd. & cannot
be altered, used or copied without the
written consent of architects atelier.

FILE NAME:- 3rd floor /

No	Date	Revision
RURAL ELECTRIFICATION CORPORATION LTD		
PALIKA BHAWAN ,R.K PURAM,NEW DELHI		
Title INTERIOR LAY OUT		
ROUTER OF CONDUCTING		

amit sahani krishna sahani s.k.sani
b.arch., mca b.arch., m and (USA) b.arch., fna

Dwg No 06

Scale

Debit	Date
PROJECT	MARCH,2007

architects atelier
architects atelier pvt. ltd.
arch tech projects pvt. ltd.

scs-8, sec-17/ie
Grandgauri - 160017
tel: 702075,715272 mobile: 9814019753 fax: 608940