


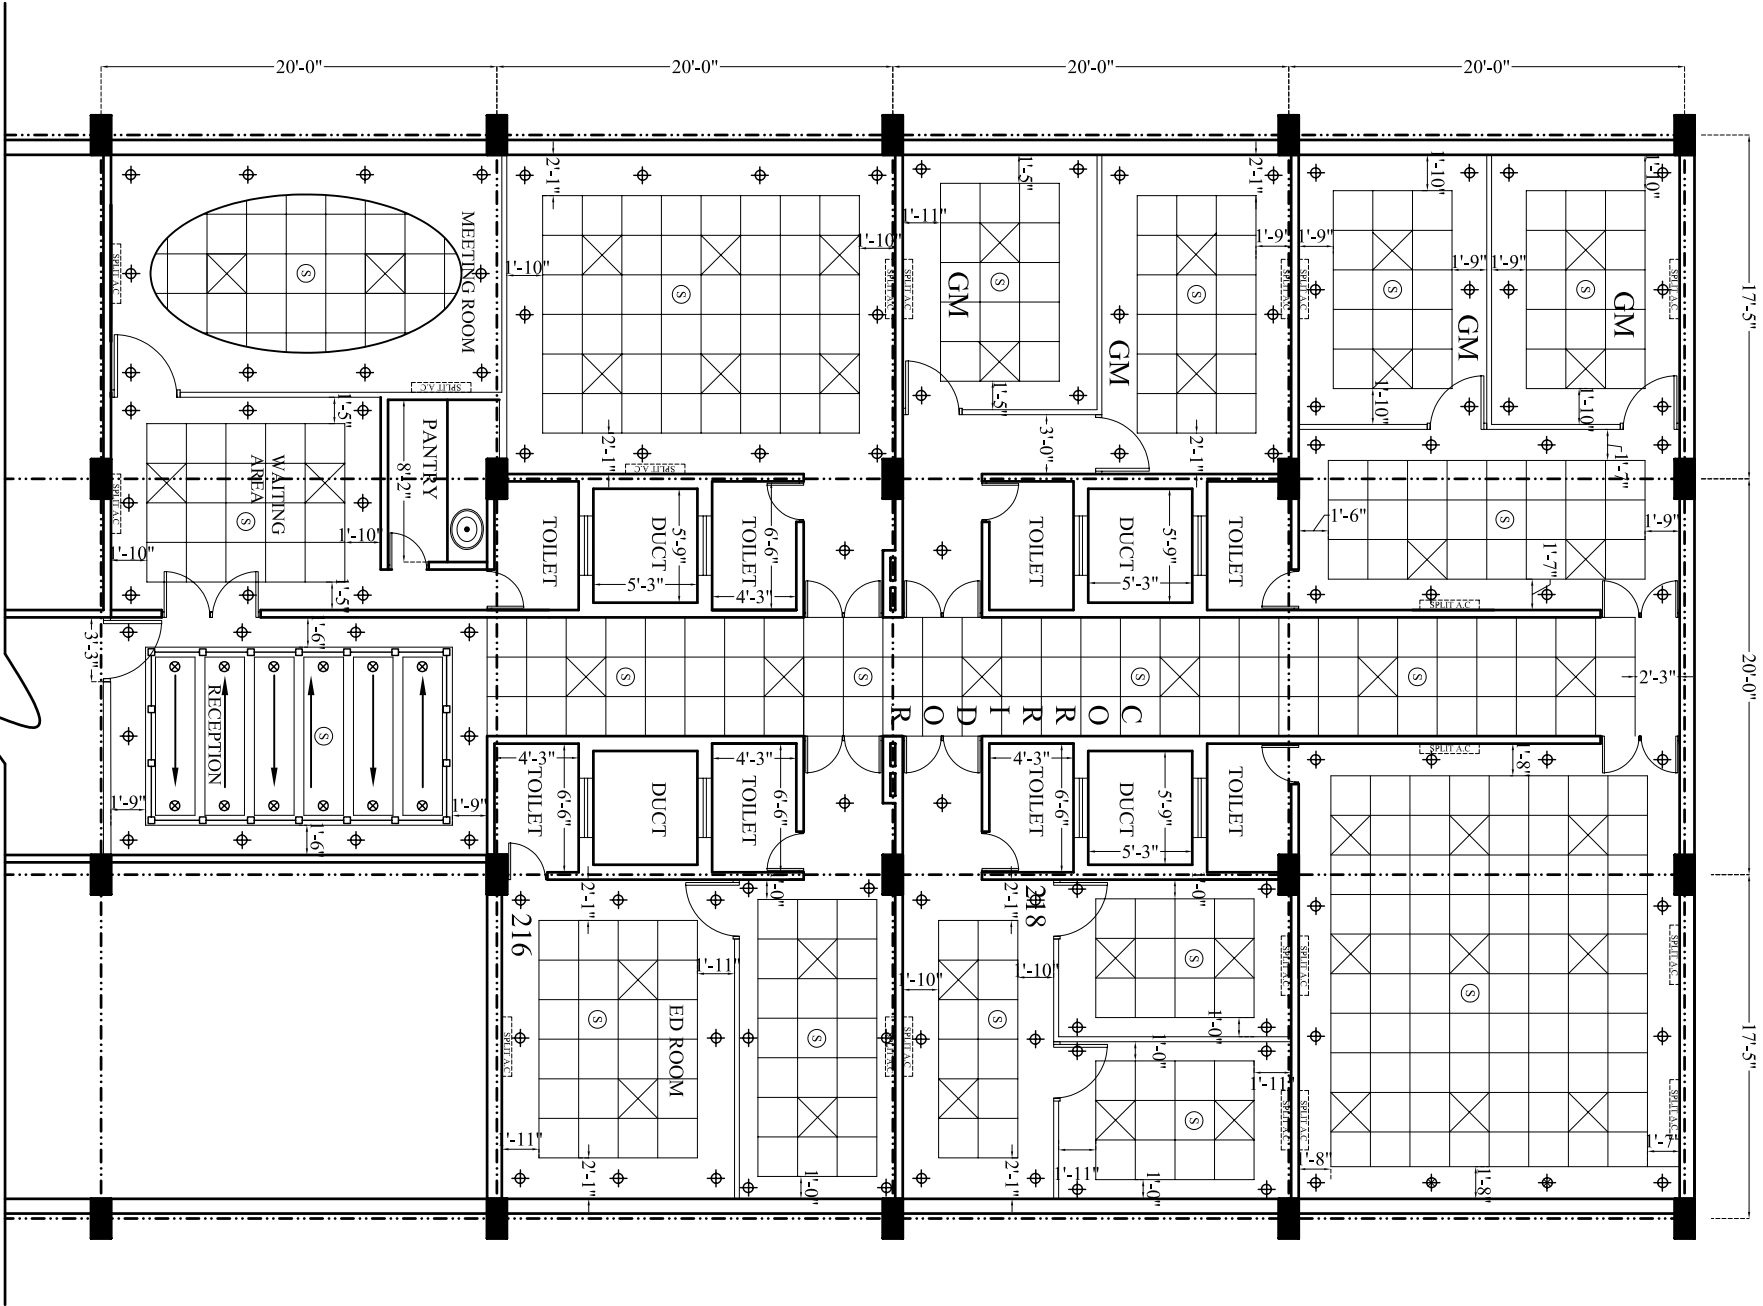

SECOND FLOOR PLAN

- ⊗ - SMOKE DETECTOR & OCCUPANCY DETECTOR
- ⊕ - SPOT LIGHT
- ⊗ - 2X2 LIGHT
- ⊗ - SPLIT AC

NOTE

this drawing is the property of architects atelier/architects atelier pvt. ltd. / arch tech projects pvt. ltd. & cannot be altered, used or copied without the written consent of architects atelier.

FILE NAME:- sec02 /

No	Date	Revision
RURAL ELECTRIFICATION CORPORATION LTD		
PALIKA BHAWAN ,R.K PURAM,NEW DELHI		
Title INTERIOR LAY OUT		
FALSE CEILING PLAN		


amit.sami krishna.sami s.k.sami
b.arch., mca b.arch., m and (USA) b.arch., fna

Dwg No 03

Scale	Date
Decit	
SIML	MARCH,2007

architects atelier
architects atelier pvt. ltd.
arch tech projects pvt. ltd.

sec-8, sec-17/c
Gurgaon-166017
tel: 702073,715272 mobile: 9814019753 fax: 606940

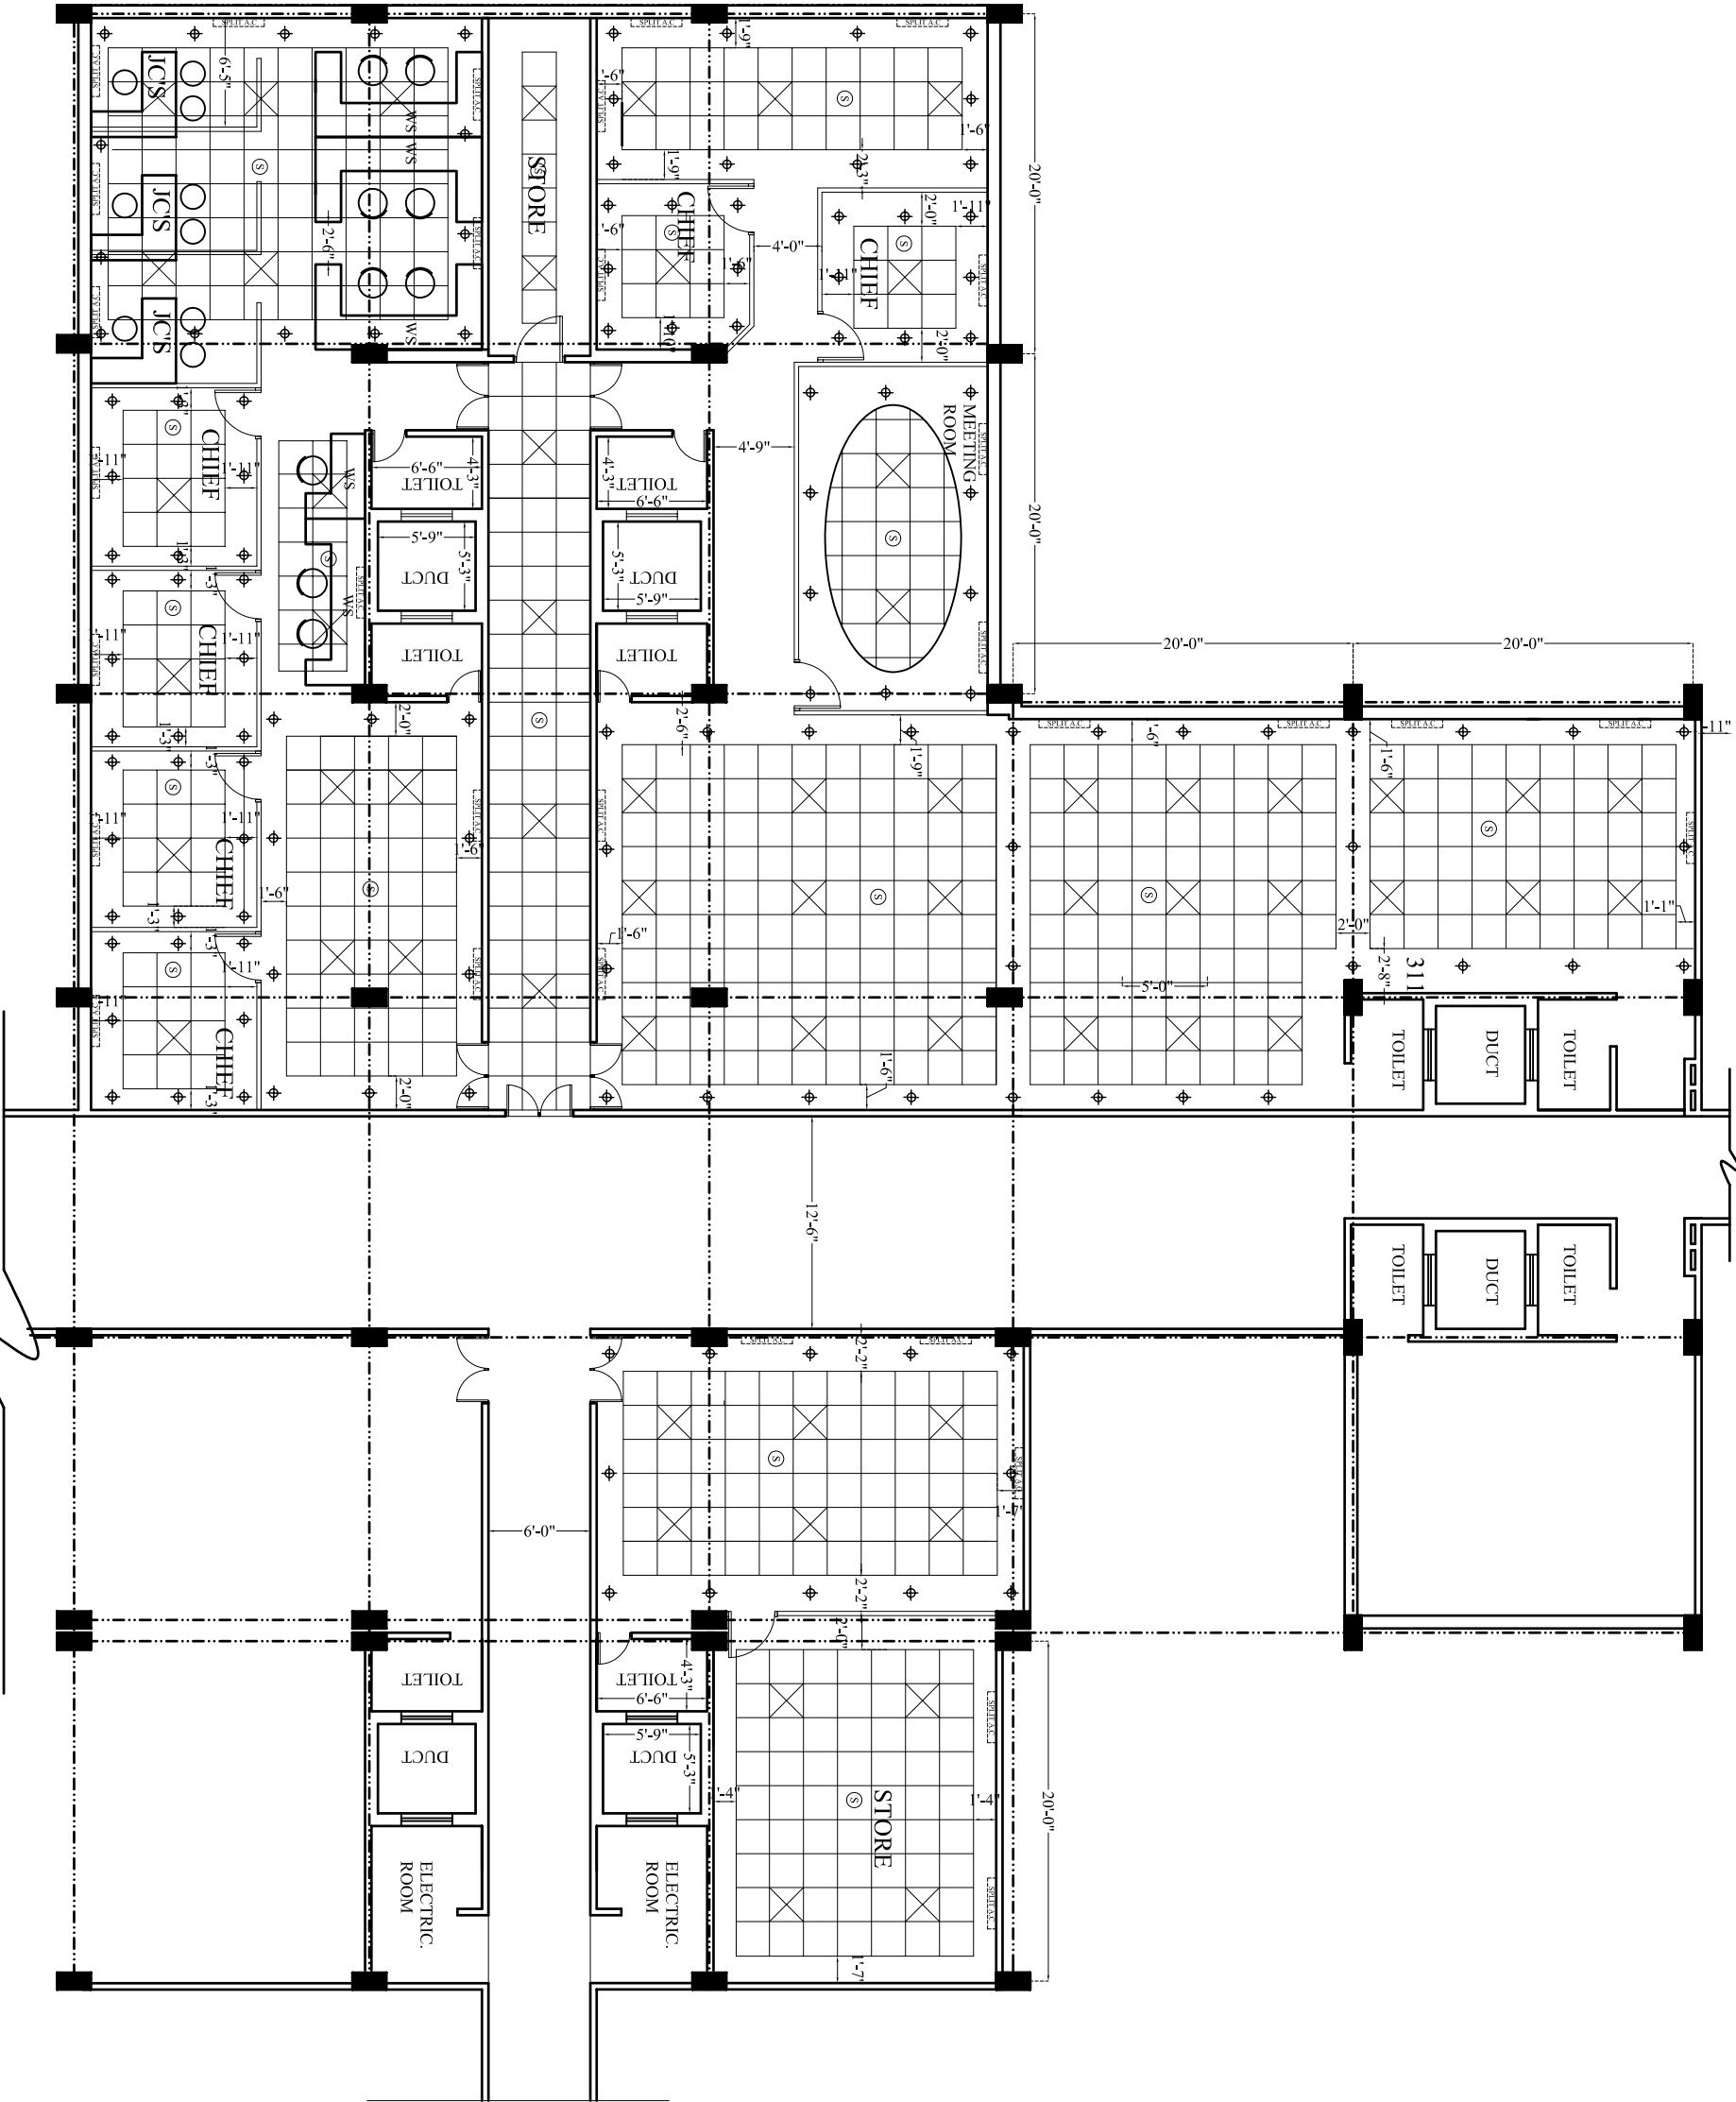

- ⑤ - SMOKE DETECTOR & OCCUPANCY DETECTOR
◆ - SPOT LIGHT
⊠ - 2X2 LIGHT
[SPLIT AC] - SPLIT AC

NOTE

this drawing is the property of
architects atelier/architects atelier pvt. ltd.
/ arch tech projects pvt. ltd. & cannot
be altered, used or copied without the
written consent of architects atelier.

FILE NAME:- s30703 /

No	Date	Revision
RURAL ELECTRIFICATION CORPORATION LTD		
PALIKA BHAWAN ,R.K PURAM,NEW DELHI		
Title INTERIOR LAY OUT		
FALSE CEILING PLAN		

amit.sami krishna.sami s.k.sami
b.arch., mca b.arch., m and (USA) b.arch., itia

Dwg No 04

Scale	Date
Debit	
SMIL	MARCH,2007

architects atelier
architects atelier pvt. ltd.
arch tech projects pvt. ltd.

sco-8, sec-17/ie
Gurgaon-166017
tel: 702075,715272 mobile: 9814019753 fax: 606940

THIRDFLOOR PLAN