

OFFICERS	NO.
ED	01
GM	04
CHIEF	02
STAFF	14
MEETING RM	01
JC	03
DC	02
RECEPTION	
PERSONS ACCOMODATED: 26 NO.	

FLOORING VITRIFIED 2X2'

NOTE
 this drawing is the property of architects atelier/architects atelier pvt. ltd. / arch tech projects pvt. ltd. & cannot be altered, used or copied without the written consent of architects atelier.

FILE NAME :- *sew2/*


No	Date	Revision
RURAL ELECTRIFICATION CORPORATION LTD		
PALIKA BHAWAN ,R.K PURAM,NEW DELHI		
Title INTERIOR LAY OUT		
SECOND FLOOR PLAN(OPTION 1)		

Scale	Date
Debit	MARCH,2007

Dwg No	01	
ami.sami	komana.sami	s.k.sami
b.arch., mca	b.arch., m.and (USA)	b.arch., fia

Scale: architects atelier
 architects atelier pvt. ltd.
 arch tech projects pvt. ltd.
 sco-8, sec-17/6
 Chandigarh-160017
 tel: 7020753,715272 mobile: 9814019753 fax: 608940

SECOND FLOOR PLAN

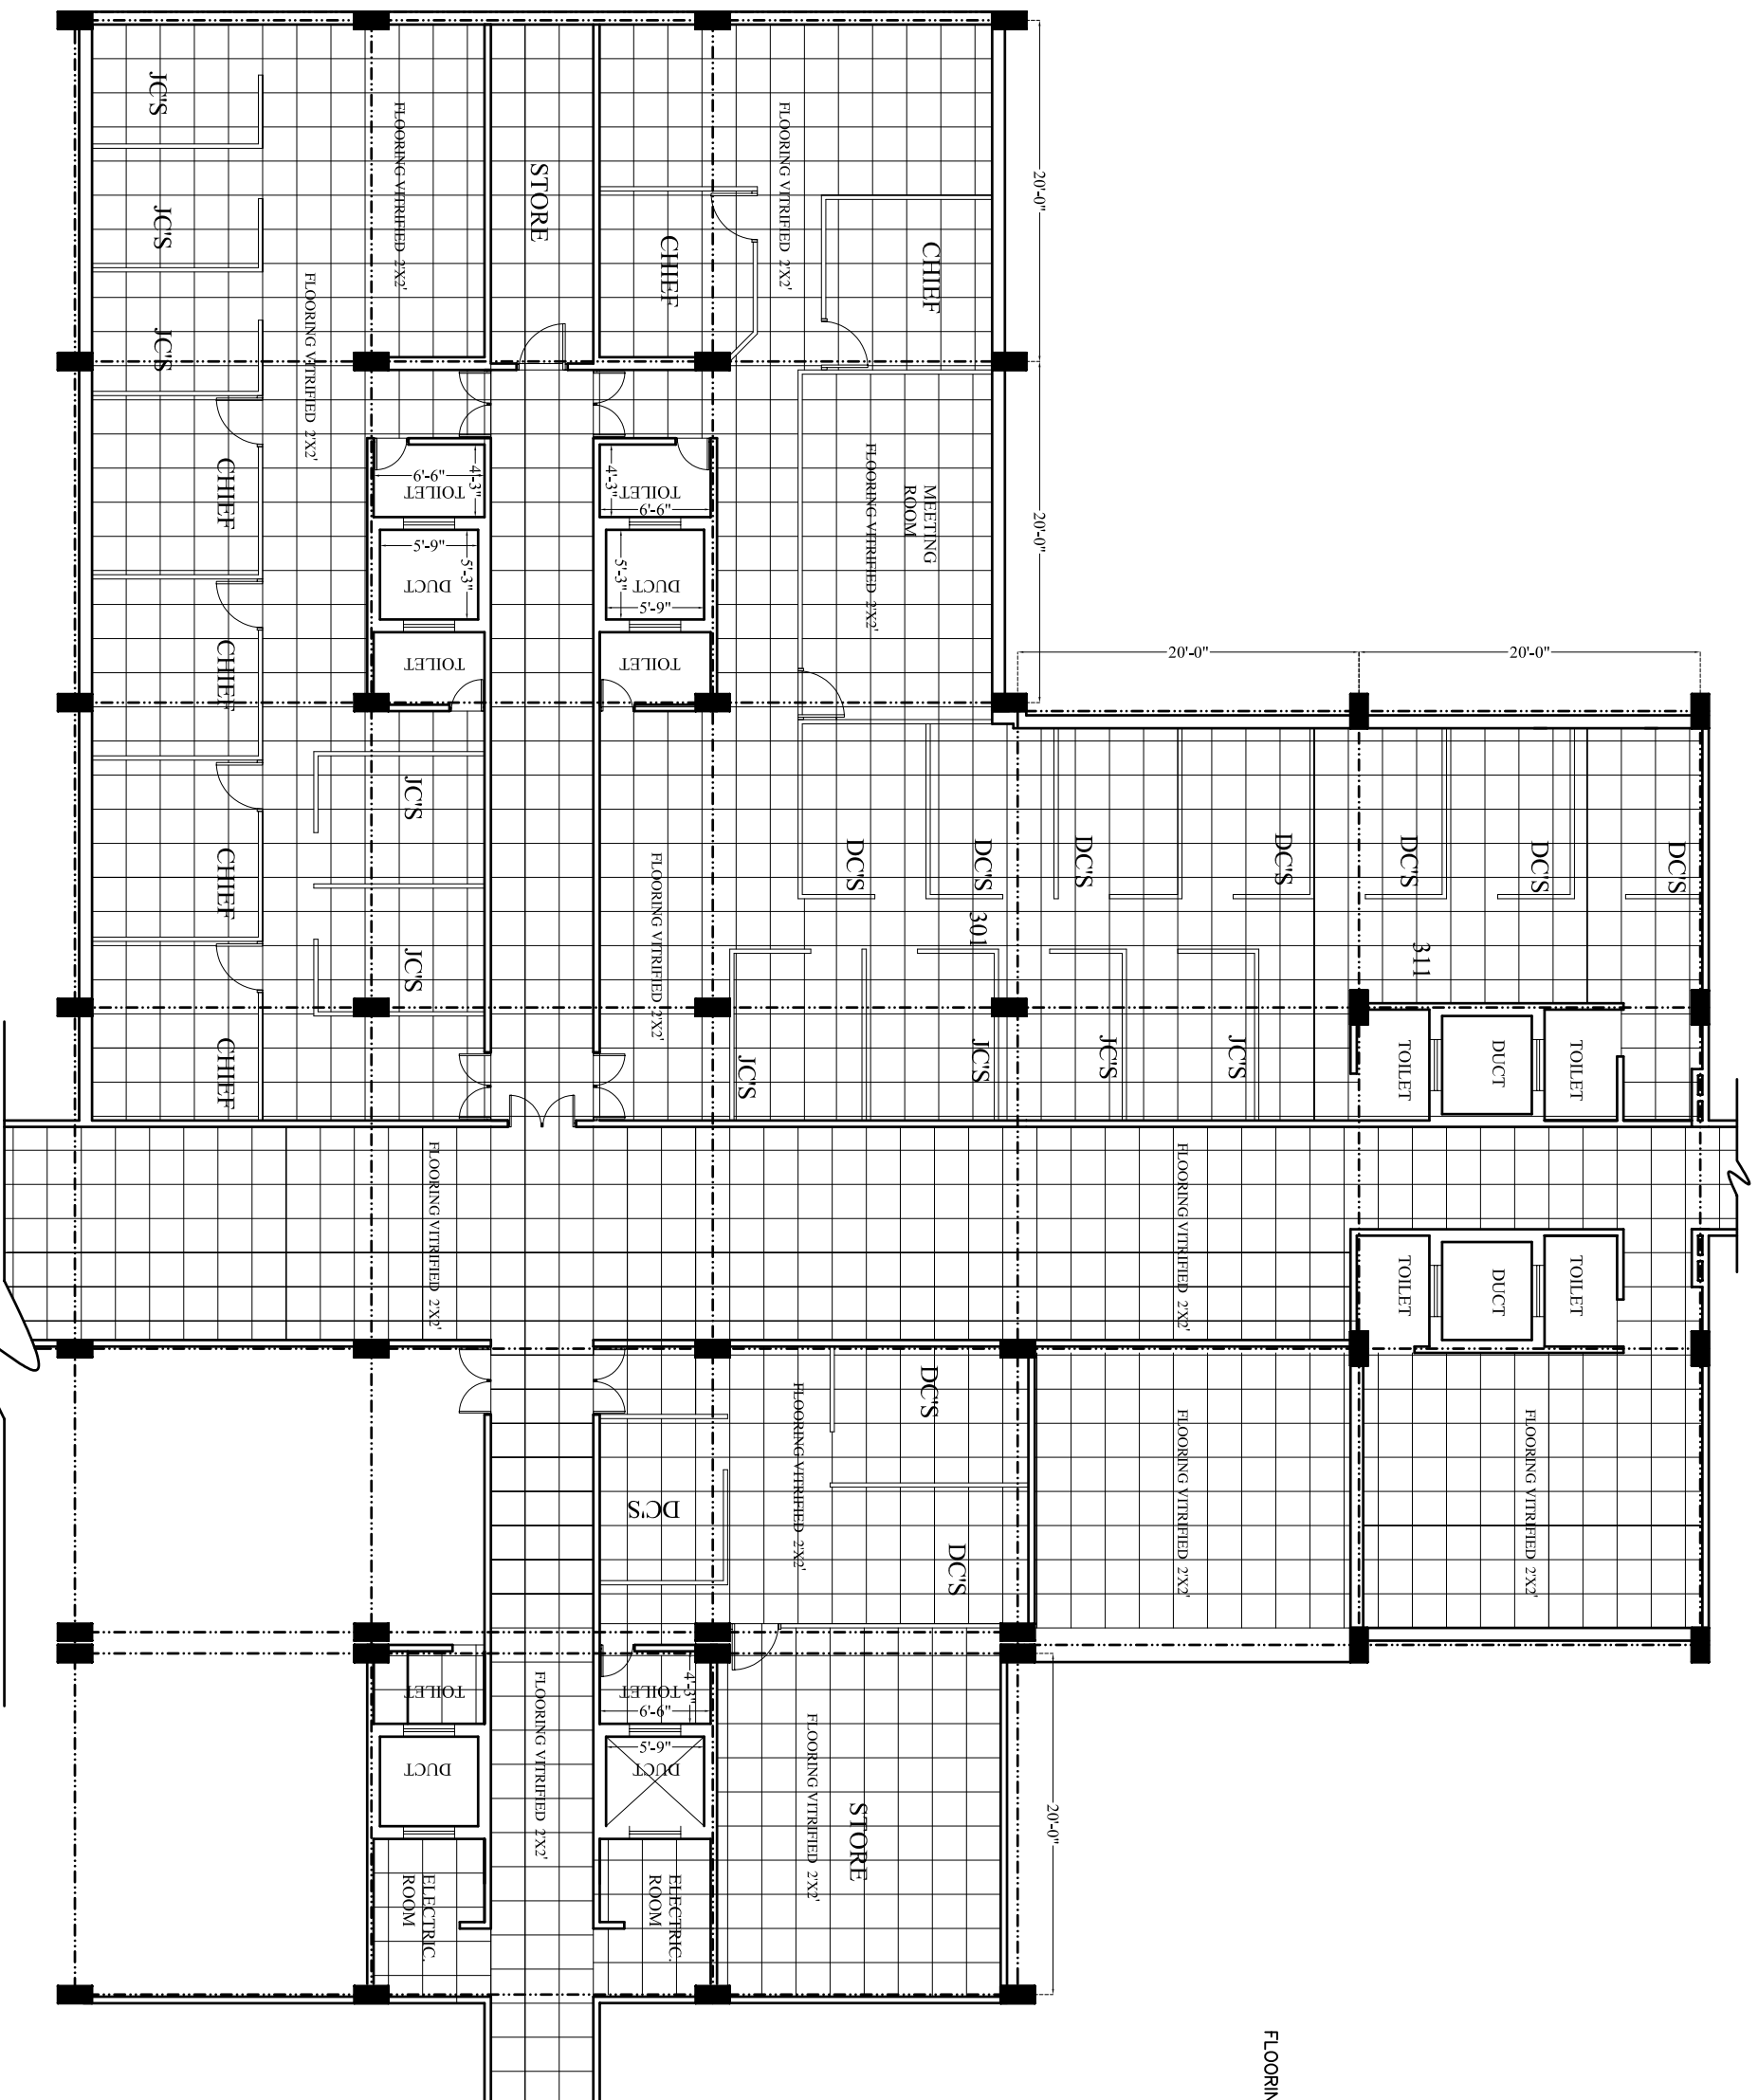

FLOORING VITRIFIED 2X2'

OFFICERS	NO.
CHIEF	04
STAFF	20
JCS	09
DCS	07
MEETING RM	01
STORE	01

PERSONS ACCOMMODATED:40 NO.
TOTAL PERSONS ACCOMMODATED
ON SECOND& &THIRDFLOOR:66NO

THIRDFLOOR PLAN

NOTE
this drawing is the property of architects atelier/architects atelier pvt. ltd. / arch tech projects pvt. ltd. & cannot be altered, used or copied without the written consent of architects atelier.

FILE NAME :- senva /

No	Date	Revision

RUBAL ELECTRIFICATION CORPORATION LTD
PALIKA BHAWAN ,R.K PURAM,NEW DELHI
The INTERIOR LAY OUT
THIRDFLOOR PLAN(OPTION 1)

amit.sami kama.sami s.k.sami
b.arch., mca b.arch., m.and (USA) b.arch., fia

Dwg No 02

Scale	Date
1:100	MARCH,2007

architects atelier
architects atelier pvt. ltd.
arch tech projects pvt. ltd.
scs-8, sec-17/6
Gurgaon-160017
tel: 702075715272 mobile: 9814019753 fax: 608940